



TYPICAL ACCESS TRACK DRAINAGE PLAN

SCALE 1:250

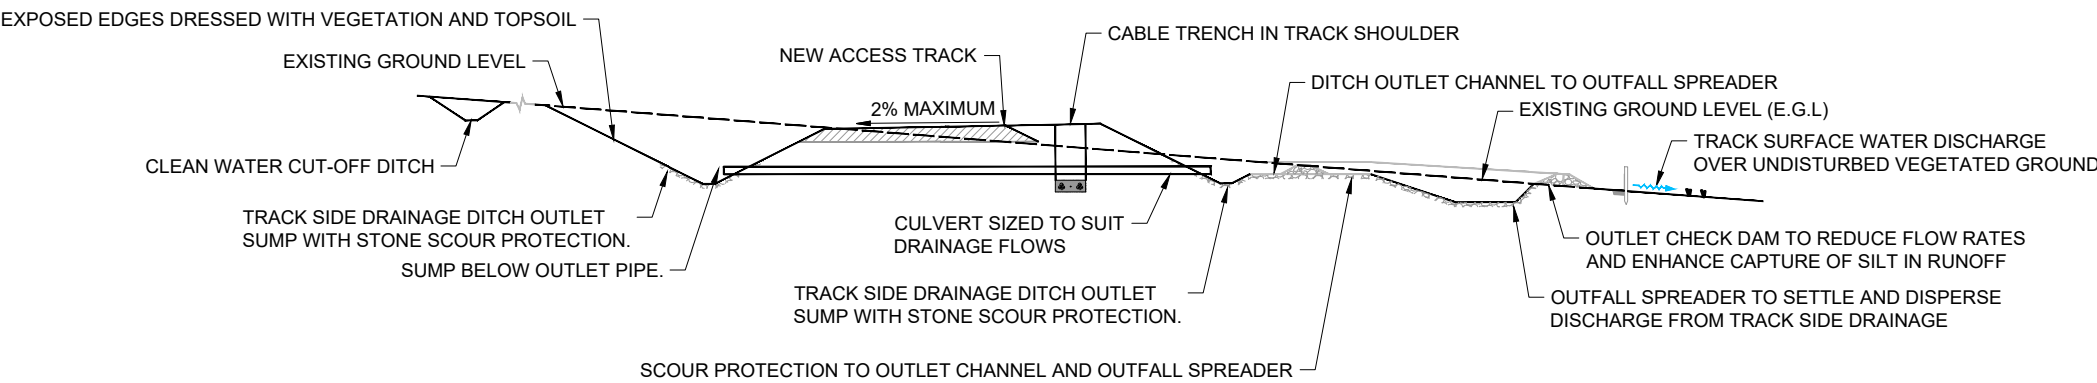

TYPICAL ACCESS TRACK DRAINAGE - SECTION A - A

 SCALE 1:250



LEGAL: NATURAL POWER CONSULTANTS LTD TAKE NO RESPONSIBILITY FOR THE ACCURACY OF DATA PROVIDED BY THIRD PARTIES.

- NOTES:**
1. ALL DIMENSIONS ARE IN METRES UNLESS OTHERWISE STATED.

A	INITIAL ISSUE	MH	MB	JS	05/07/24
REV	DESCRIPTION	BY	CH	APP	DATE

CLIENT: **VATTENFALL**

NATURAL POWER CONSULTANTS LTD.
120 BATH STREET
SECOND FLOOR
GLASGOW
G2 2EN
SCOTLAND,UK
TEL: +44 (0) 1786 542 300
WWW.NATURALPOWER.COM



IFS DOC NO.: 1356561	IFS ACTIVITY: 80.830
SCALE: 1:250 @ A3	SHEET NO.: 2 OF 2

STATUS: **FOR INFORMATION**

PROJECT: SOUTH KYLE II WIND FARM

DRAWING TITLE: FIGURE 4.6
INDICATIVE ACCESS TRACK DRAINAGE

DRAWING NO.: 17960_DET_3006	REVISION A
-----------------------------	-------------------